


1. FLOOR PLAN
SCALE: 1/8" = 1'-0"

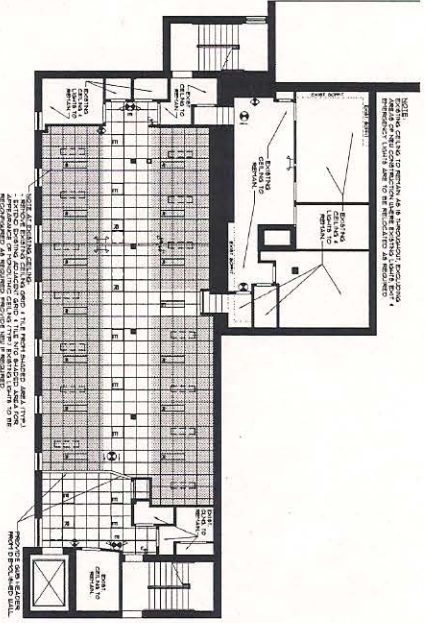

2. REFLECTED CEILING PLAN
SCALE: 1/8" = 1'-0"

DOOR SCHEDULE

TYPE	SIZE	DOOR	FRAME	GLASS	REQUIRED
1	3'-6" x 7'-6" x 1'-0"	GLASS	STEEL	1	DOOR IN RECEPTION
2	2'-6" x 7'-6" x 1'-0"	GLASS	STEEL	1	DOOR IN OFFICE
3	2'-6" x 7'-6" x 1'-0"	GLASS	STEEL	1	DOOR IN OFFICE
4	2'-6" x 7'-6" x 1'-0"	GLASS	STEEL	1	DOOR IN OFFICE
5	2'-6" x 7'-6" x 1'-0"	GLASS	STEEL	1	DOOR IN OFFICE

ELECTRICAL LEGEND & NOTES

SYMBOL	DESCRIPTION
[Symbol]	REMOVE EXISTING ELECTRICAL RECEPTACLE VENTILATION OF ALL EXISTING ELECTRICAL RECEPTACLES AS REQUIRED.
[Symbol]	INSTALL NEW ELECTRICAL RECEPTACLES AS REQUIRED.
[Symbol]	REMOVE EXISTING ELECTRICAL RECEPTACLE VENTILATION OF ALL EXISTING ELECTRICAL RECEPTACLES AS REQUIRED.
[Symbol]	INSTALL NEW ELECTRICAL RECEPTACLES AS REQUIRED.
[Symbol]	REMOVE EXISTING ELECTRICAL RECEPTACLE VENTILATION OF ALL EXISTING ELECTRICAL RECEPTACLES AS REQUIRED.
[Symbol]	INSTALL NEW ELECTRICAL RECEPTACLES AS REQUIRED.

REFLECTED CEILING LEGEND & NOTES

SYMBOL	DESCRIPTION
[Symbol]	REMOVE EXISTING 2' X 2' CEILING MOUNTED LIGHT FIXTURES WITH ELECTRIC BALLASTS.
[Symbol]	INSTALL NEW 2' X 2' CEILING MOUNTED LIGHT FIXTURES WITH ELECTRIC BALLASTS.
[Symbol]	REMOVE EXISTING 2' X 2' CEILING MOUNTED LIGHT FIXTURES WITH ELECTRIC BALLASTS.
[Symbol]	INSTALL NEW 2' X 2' CEILING MOUNTED LIGHT FIXTURES WITH ELECTRIC BALLASTS.
[Symbol]	REMOVE EXISTING 2' X 2' CEILING MOUNTED LIGHT FIXTURES WITH ELECTRIC BALLASTS.
[Symbol]	INSTALL NEW 2' X 2' CEILING MOUNTED LIGHT FIXTURES WITH ELECTRIC BALLASTS.

FINISHES

1. REMOVE ALL EXISTING FINISHES AT WORK AREA. REMOVE ALL EXISTING FINISHES AT WORK AREA. REMOVE ALL EXISTING FINISHES AT WORK AREA. REMOVE ALL EXISTING FINISHES AT WORK AREA.
2. INSTALL NEW FINISHES AT WORK AREA. INSTALL NEW FINISHES AT WORK AREA. INSTALL NEW FINISHES AT WORK AREA. INSTALL NEW FINISHES AT WORK AREA.
3. REMOVE ALL EXISTING FINISHES AT WORK AREA. REMOVE ALL EXISTING FINISHES AT WORK AREA. REMOVE ALL EXISTING FINISHES AT WORK AREA. REMOVE ALL EXISTING FINISHES AT WORK AREA.
4. INSTALL NEW FINISHES AT WORK AREA. INSTALL NEW FINISHES AT WORK AREA. INSTALL NEW FINISHES AT WORK AREA. INSTALL NEW FINISHES AT WORK AREA.

CODE ANALYSIS

AT WORK AREA THE OWNER HAS REQUESTED THE FOLLOWING CODE ANALYSIS:
 BUILDING CODE: 1.0
 FIRE CODE: 1.0
 MECHANICAL CODE: 1.0
 ELECTRICAL CODE: 1.0
 PLUMBING CODE: 1.0
 GAS CODE: 1.0
 HAZARDOUS WASTE CODE: 1.0
 ELEVATOR CODE: 1.0
 ENERGY CODE: 1.0
 ASBESTOS ABATEMENT CODE: 1.0
 LEAD ABATEMENT CODE: 1.0
 RADON ABATEMENT CODE: 1.0
 AIR QUALITY CODE: 1.0
 SOUND AND VIBRATION CODE: 1.0
 TRANSPORTATION CODE: 1.0
 UTILITIES CODE: 1.0
 WATER SUPPLY CODE: 1.0
 WASTE MANAGEMENT CODE: 1.0
 WEATHERIZATION CODE: 1.0
 ZONING CODE: 1.0

DEMOLITION NOTES

THE GENERAL CONTRACTOR SHALL REMOVE ALL EXISTING FINISHES AND MATERIALS AT THE WORK AREA. THE GENERAL CONTRACTOR SHALL REMOVE ALL EXISTING FINISHES AND MATERIALS AT THE WORK AREA. THE GENERAL CONTRACTOR SHALL REMOVE ALL EXISTING FINISHES AND MATERIALS AT THE WORK AREA. THE GENERAL CONTRACTOR SHALL REMOVE ALL EXISTING FINISHES AND MATERIALS AT THE WORK AREA.

GENERAL NOTES

1. ALL WORK TO BE DONE IN ACCORDANCE WITH ALL APPLICABLE FEDERAL, STATE, LOCAL, COUNTY AND MUNICIPAL CODES.
 2. ALL WORK SHALL BE DONE IN ACCORDANCE WITH ALL APPLICABLE FEDERAL, STATE, LOCAL, COUNTY AND MUNICIPAL CODES.
 3. ALL WORK SHALL BE DONE IN ACCORDANCE WITH ALL APPLICABLE FEDERAL, STATE, LOCAL, COUNTY AND MUNICIPAL CODES.
 4. ALL WORK SHALL BE DONE IN ACCORDANCE WITH ALL APPLICABLE FEDERAL, STATE, LOCAL, COUNTY AND MUNICIPAL CODES.

PARTITION LEGEND

SYMBOL	DESCRIPTION
[Symbol]	REMOVE EXISTING PARTITION WALLS AND CEILING AS REQUIRED BY THE FINISH SCHEDULE.
[Symbol]	INSTALL NEW PARTITION WALLS AND CEILING AS REQUIRED BY THE FINISH SCHEDULE.

LEGEND

SYMBOL	DESCRIPTION
[Symbol]	REMOVE EXISTING PARTITION WALLS AND CEILING AS REQUIRED BY THE FINISH SCHEDULE.
[Symbol]	INSTALL NEW PARTITION WALLS AND CEILING AS REQUIRED BY THE FINISH SCHEDULE.


LIFE SAFETY LEGEND

SYMBOL	DESCRIPTION
[Symbol]	REMOVE EXISTING PARTITION WALLS AND CEILING AS REQUIRED BY THE FINISH SCHEDULE.
[Symbol]	INSTALL NEW PARTITION WALLS AND CEILING AS REQUIRED BY THE FINISH SCHEDULE.

NOTES TO BIDDERS

1. WORK TO BE DONE IN ACCORDANCE WITH ALL APPLICABLE FEDERAL, STATE, LOCAL, COUNTY AND MUNICIPAL CODES.
 2. ALL WORK SHALL BE DONE IN ACCORDANCE WITH ALL APPLICABLE FEDERAL, STATE, LOCAL, COUNTY AND MUNICIPAL CODES.
 3. ALL WORK SHALL BE DONE IN ACCORDANCE WITH ALL APPLICABLE FEDERAL, STATE, LOCAL, COUNTY AND MUNICIPAL CODES.

 KEY PLAN



POLEK SCHWARTZ ARCHITECTS
 1120 West Chester Road, Suite 309, Berwyn, PA 19312
 (610) 688-2525

CURVES
 2050 WEST CHESTER PIKE
 FIRST FLOOR
 HAVERTOWN, PA 19083
 THE BUCCINI POLLIN GROUP

NO.	DATE	DESCRIPTION
1	09/29/2008	ISSUED FOR BIDDING
2	10/15/2008	REVISED

PROJECT NO.: 28450-22
 DRAWN BY: JWW

A-1